





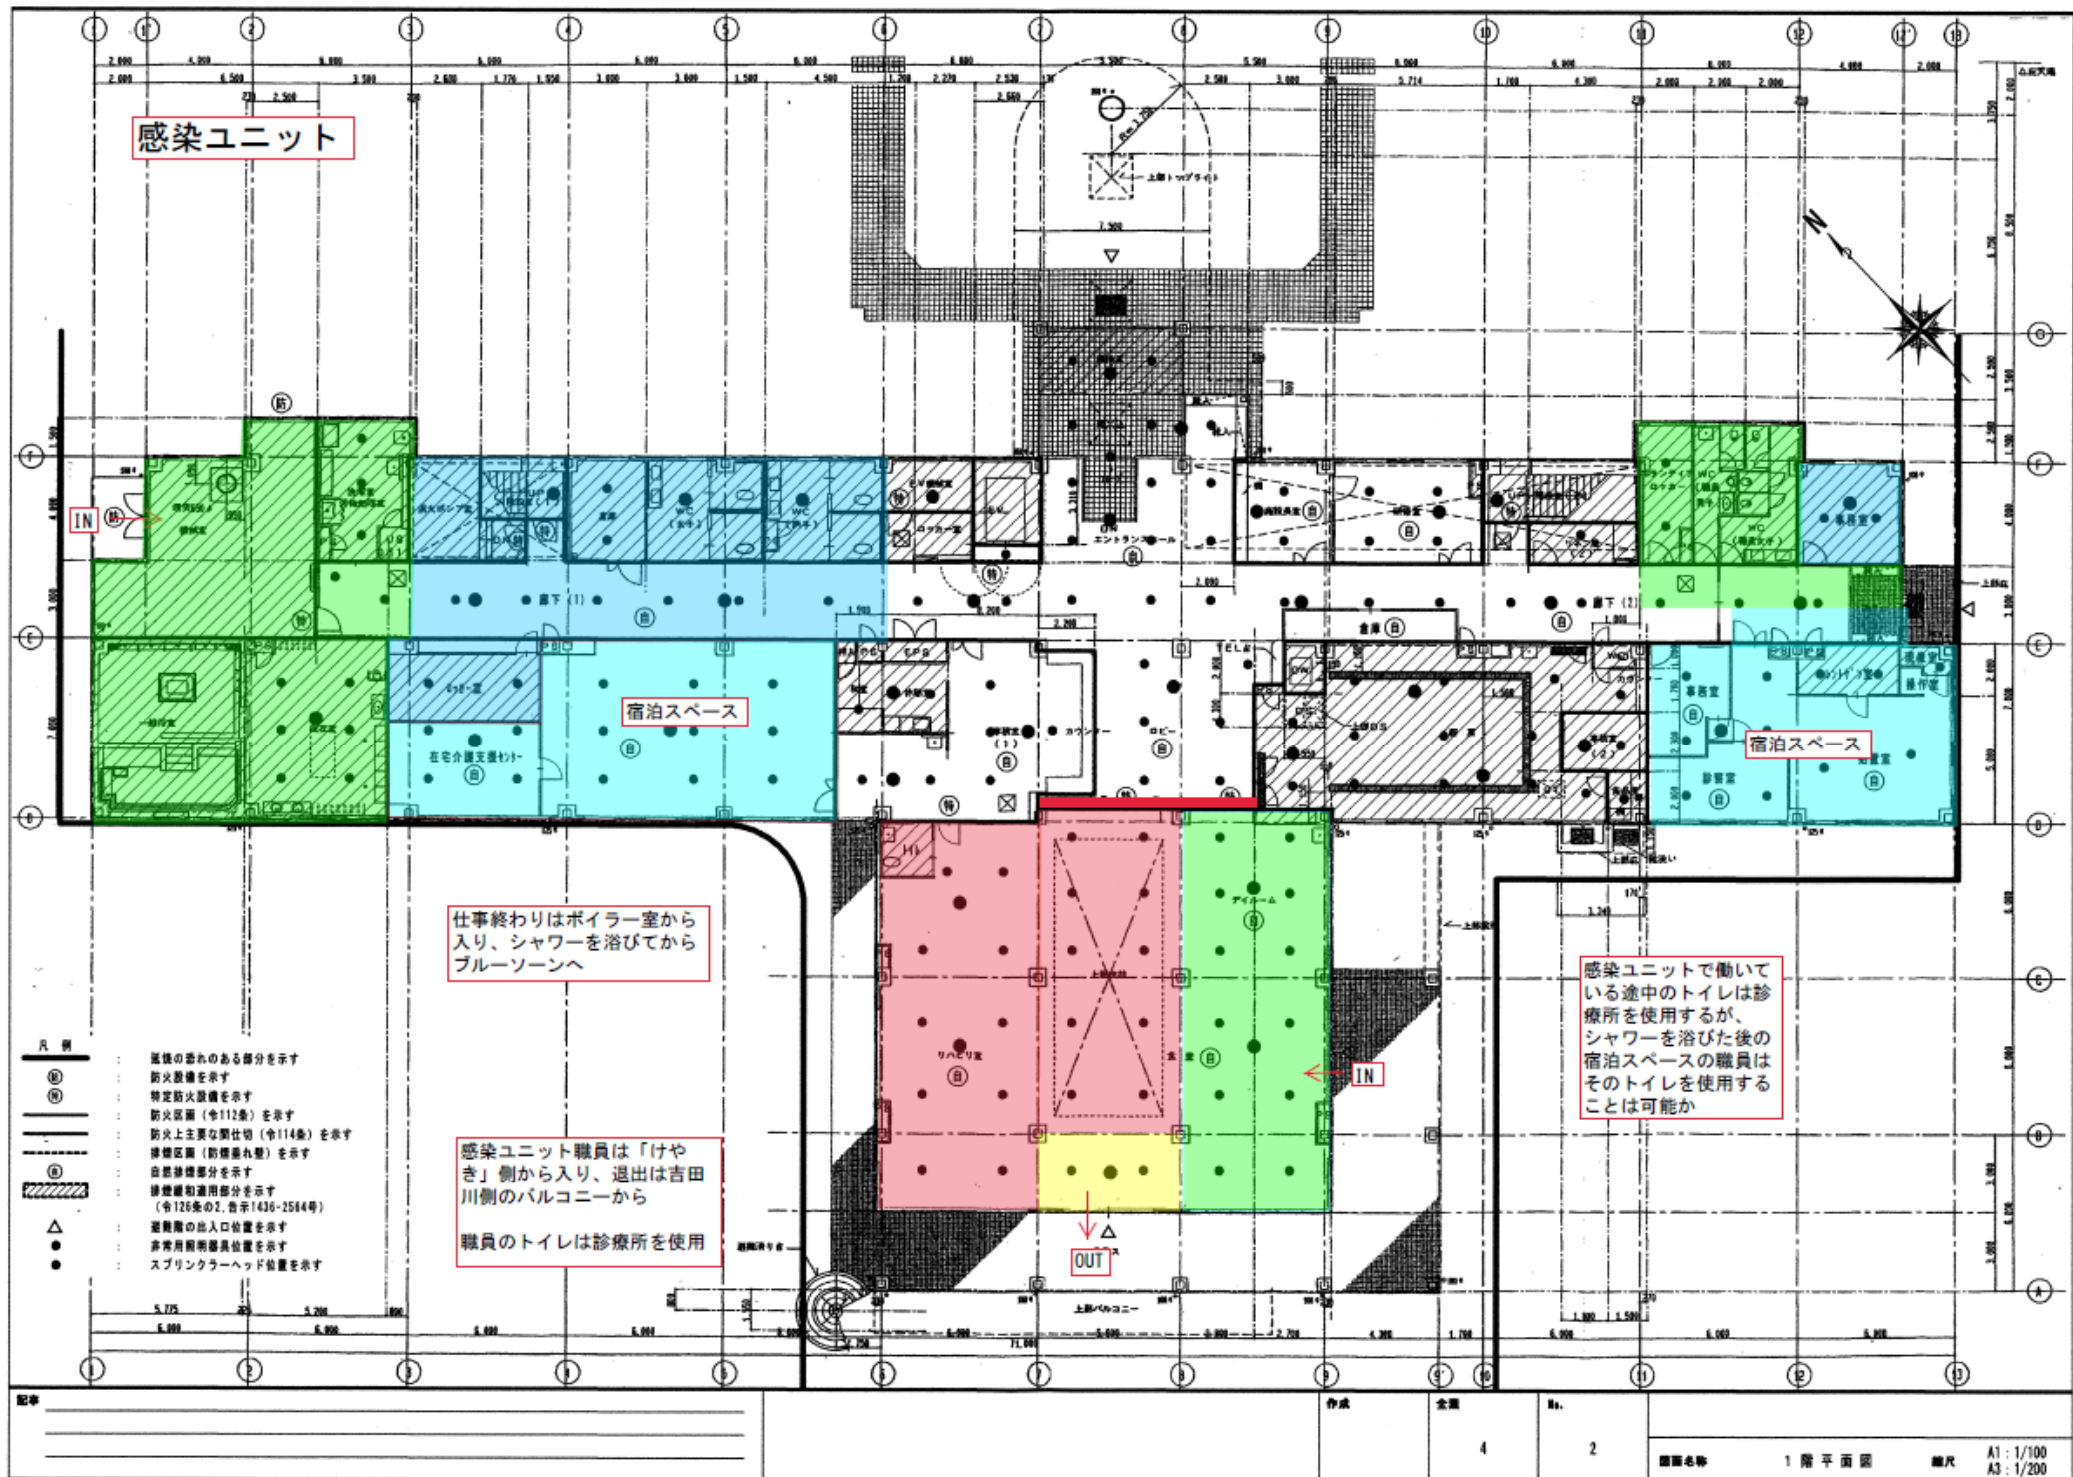

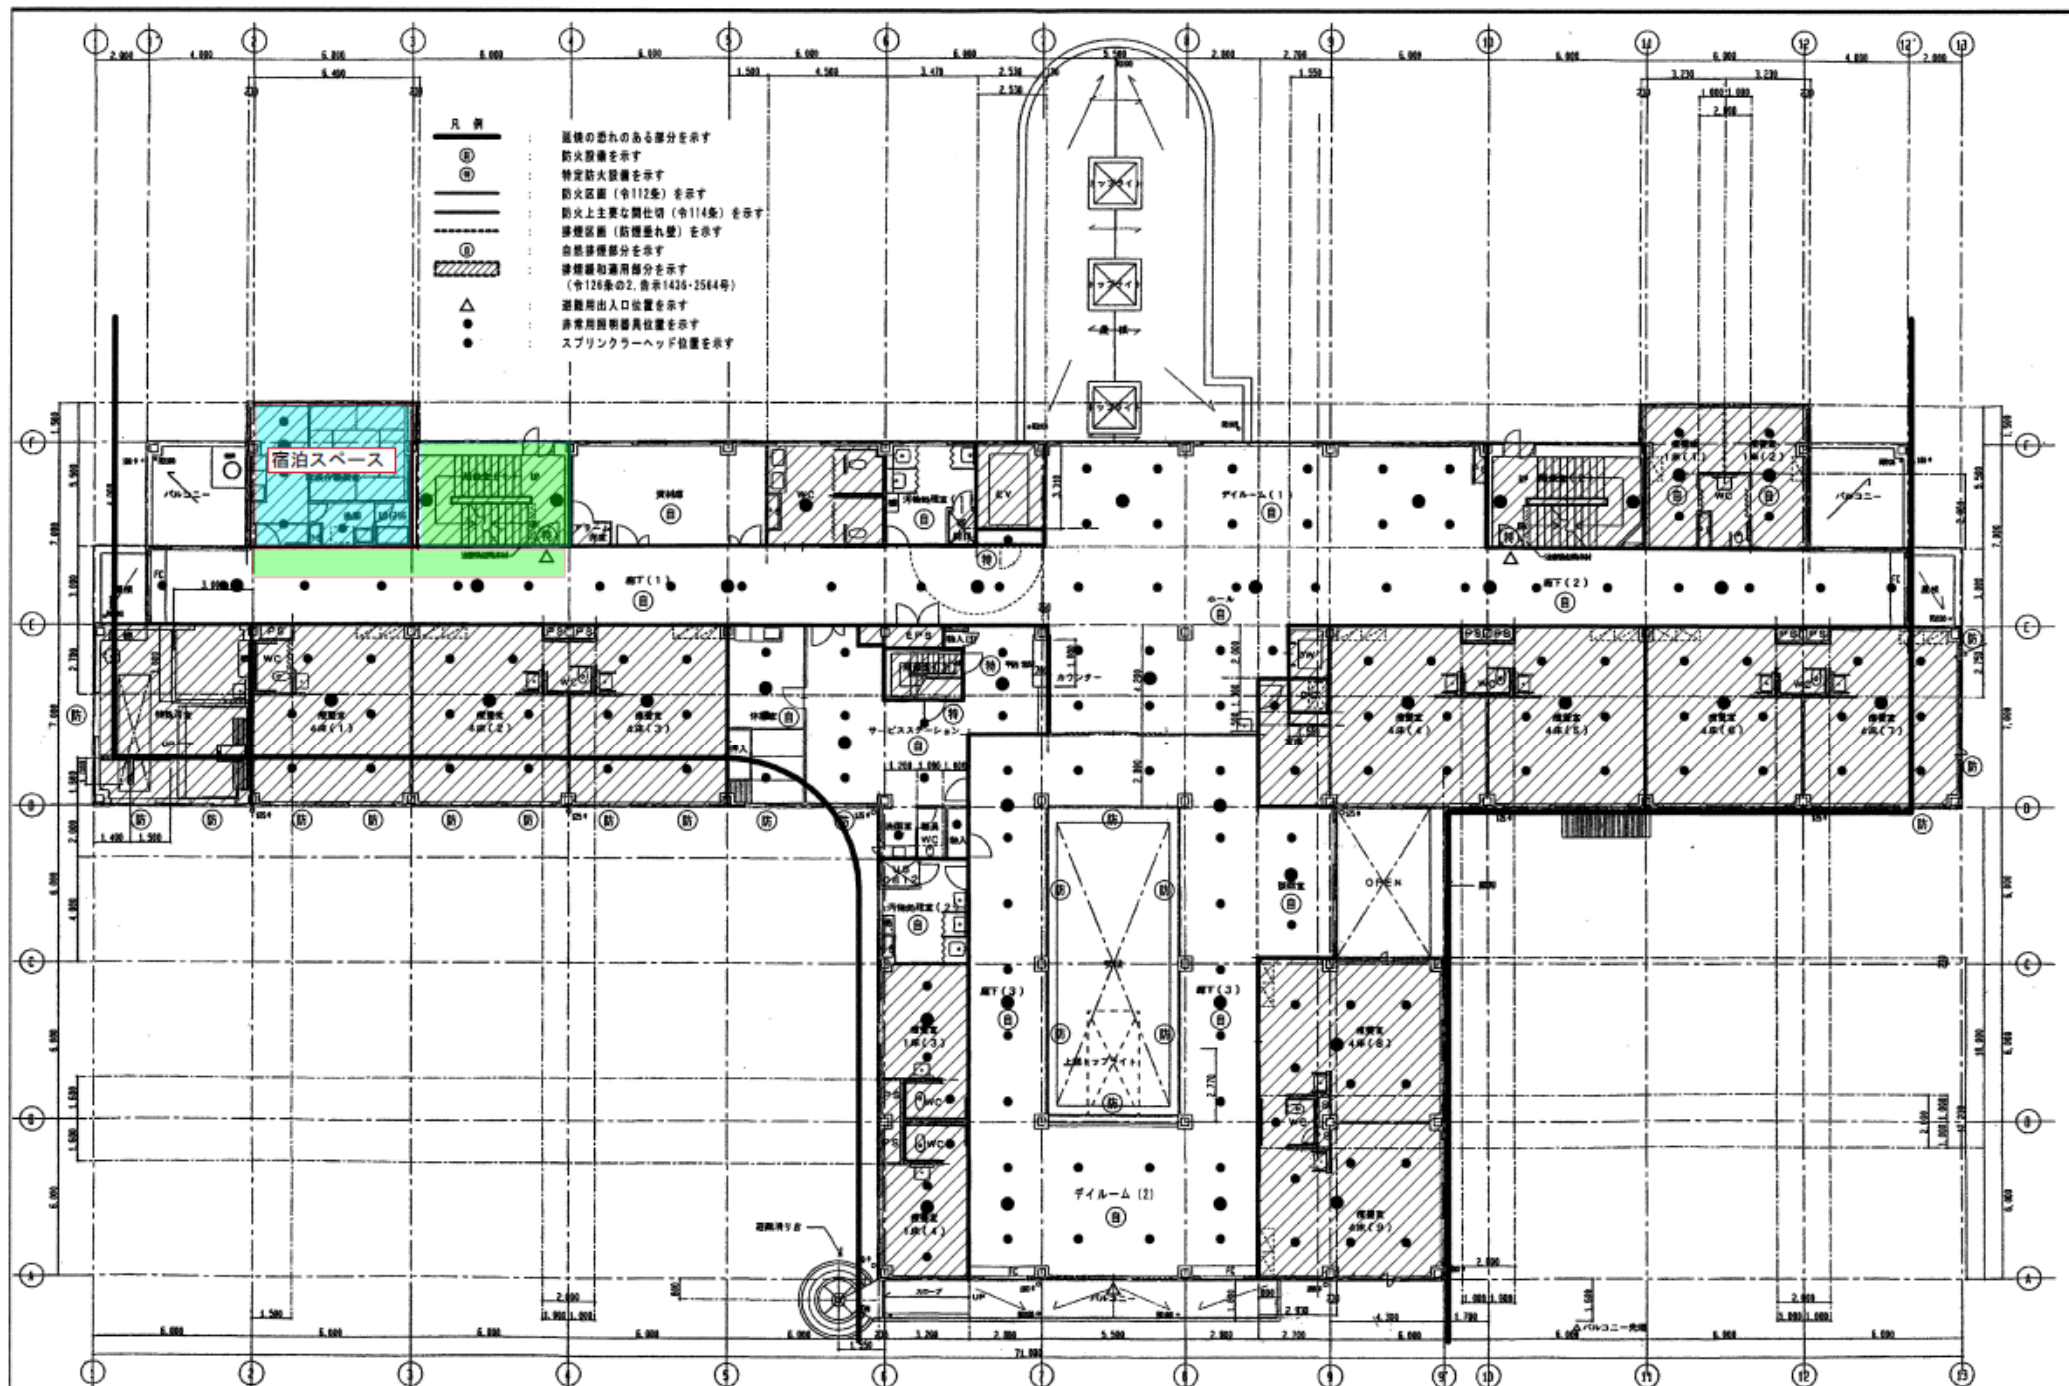

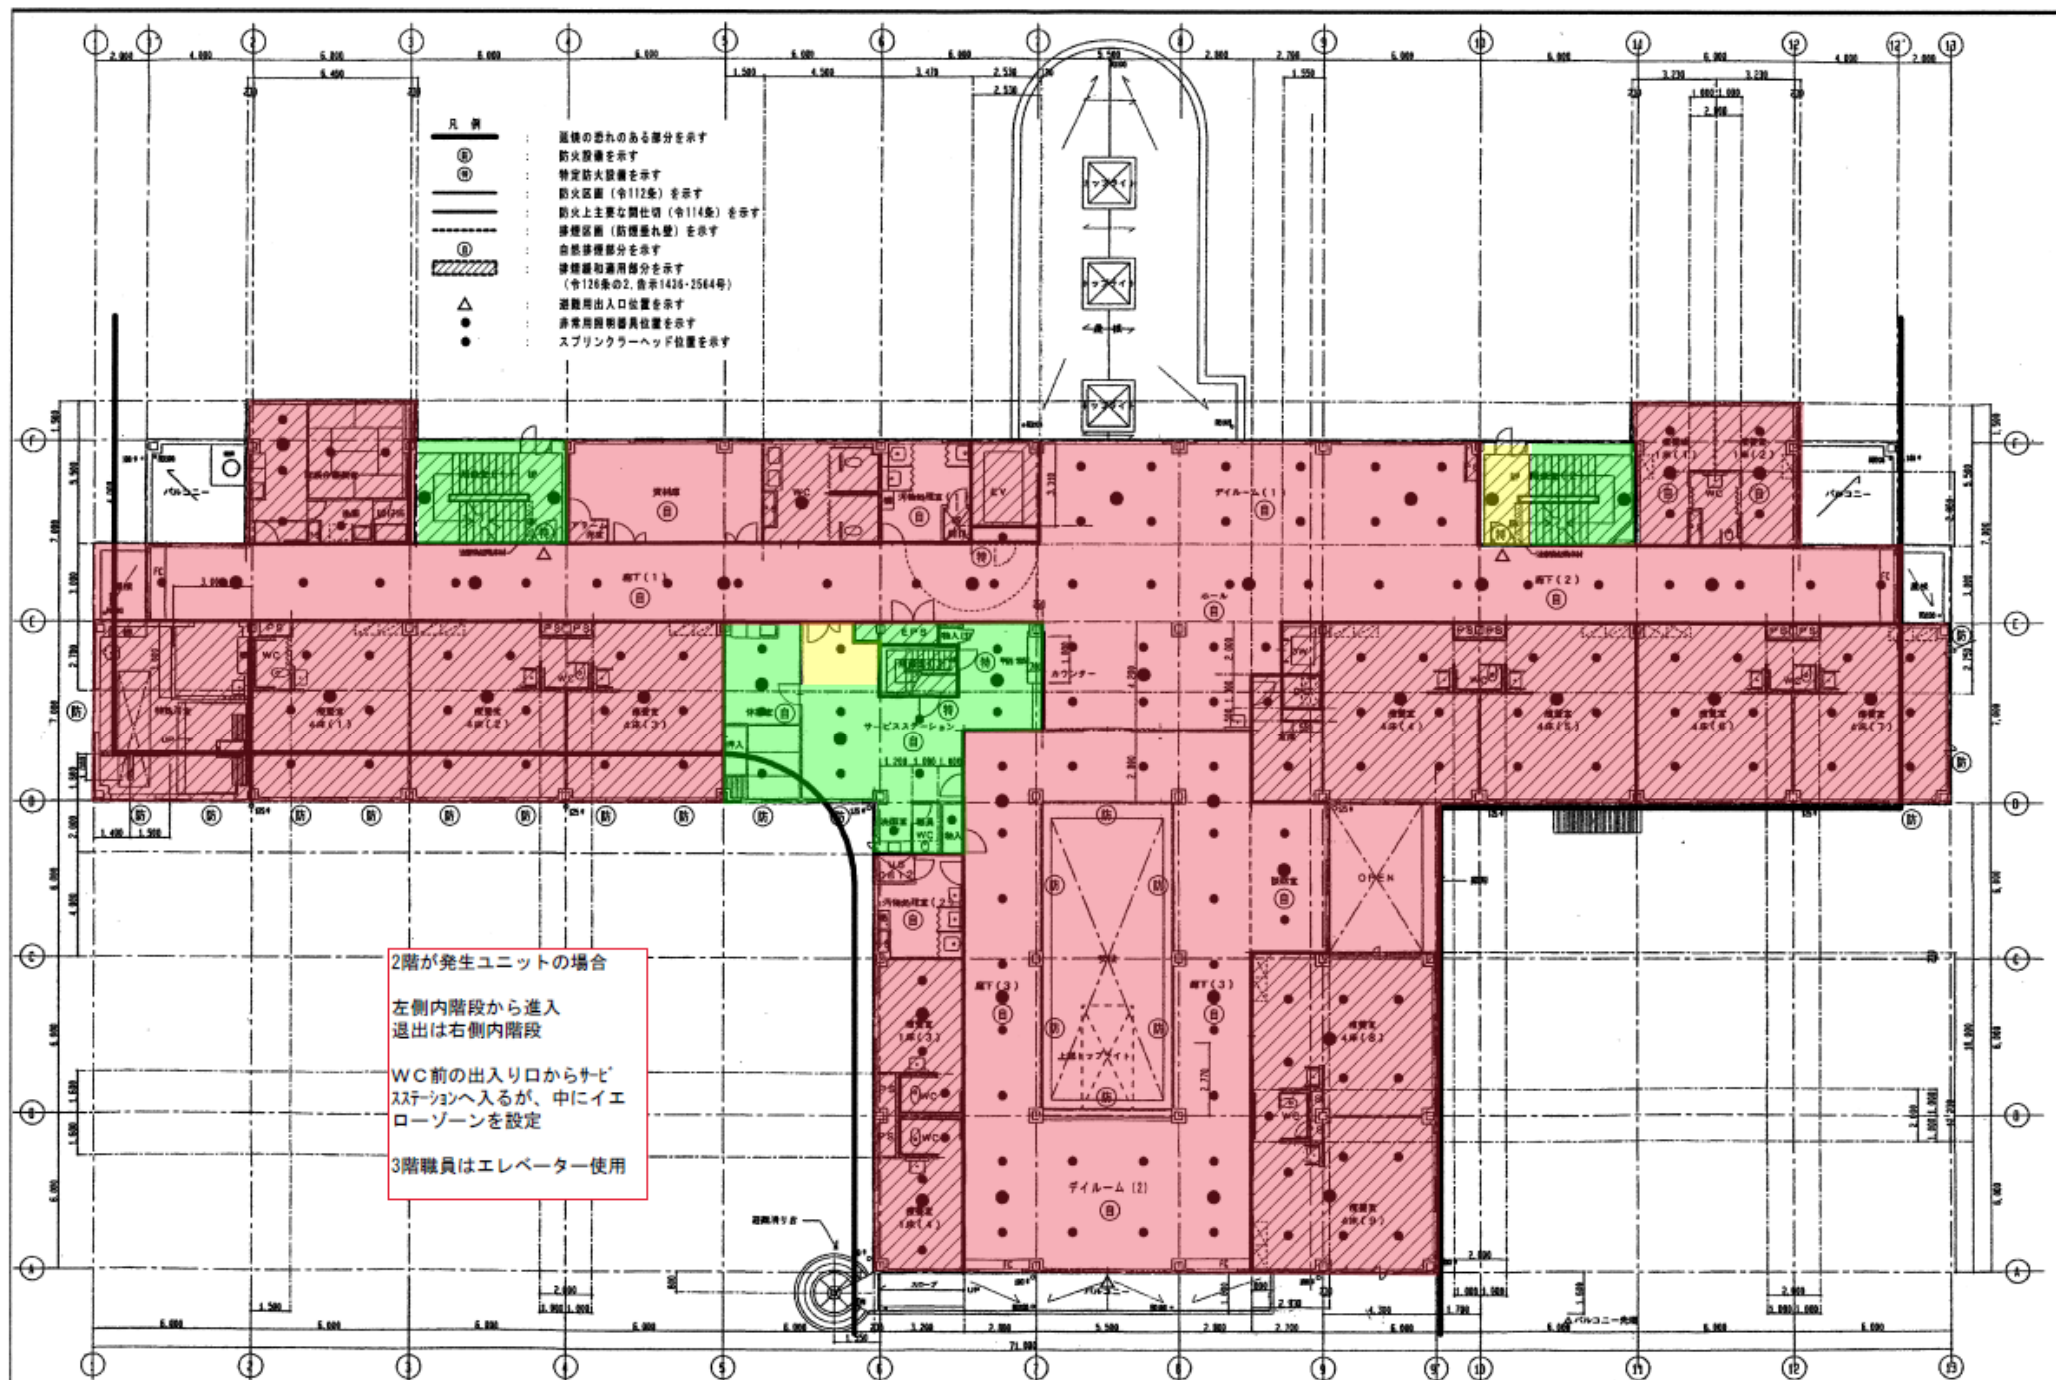

配管 _____ _____ _____	作成 _____ _____ _____	全室 4	№. 3	図面名称 2 階 平 面 図 縮尺 A1: 1/100 A3: 1/200
-------------------------------	-------------------------------	---------	---------	---

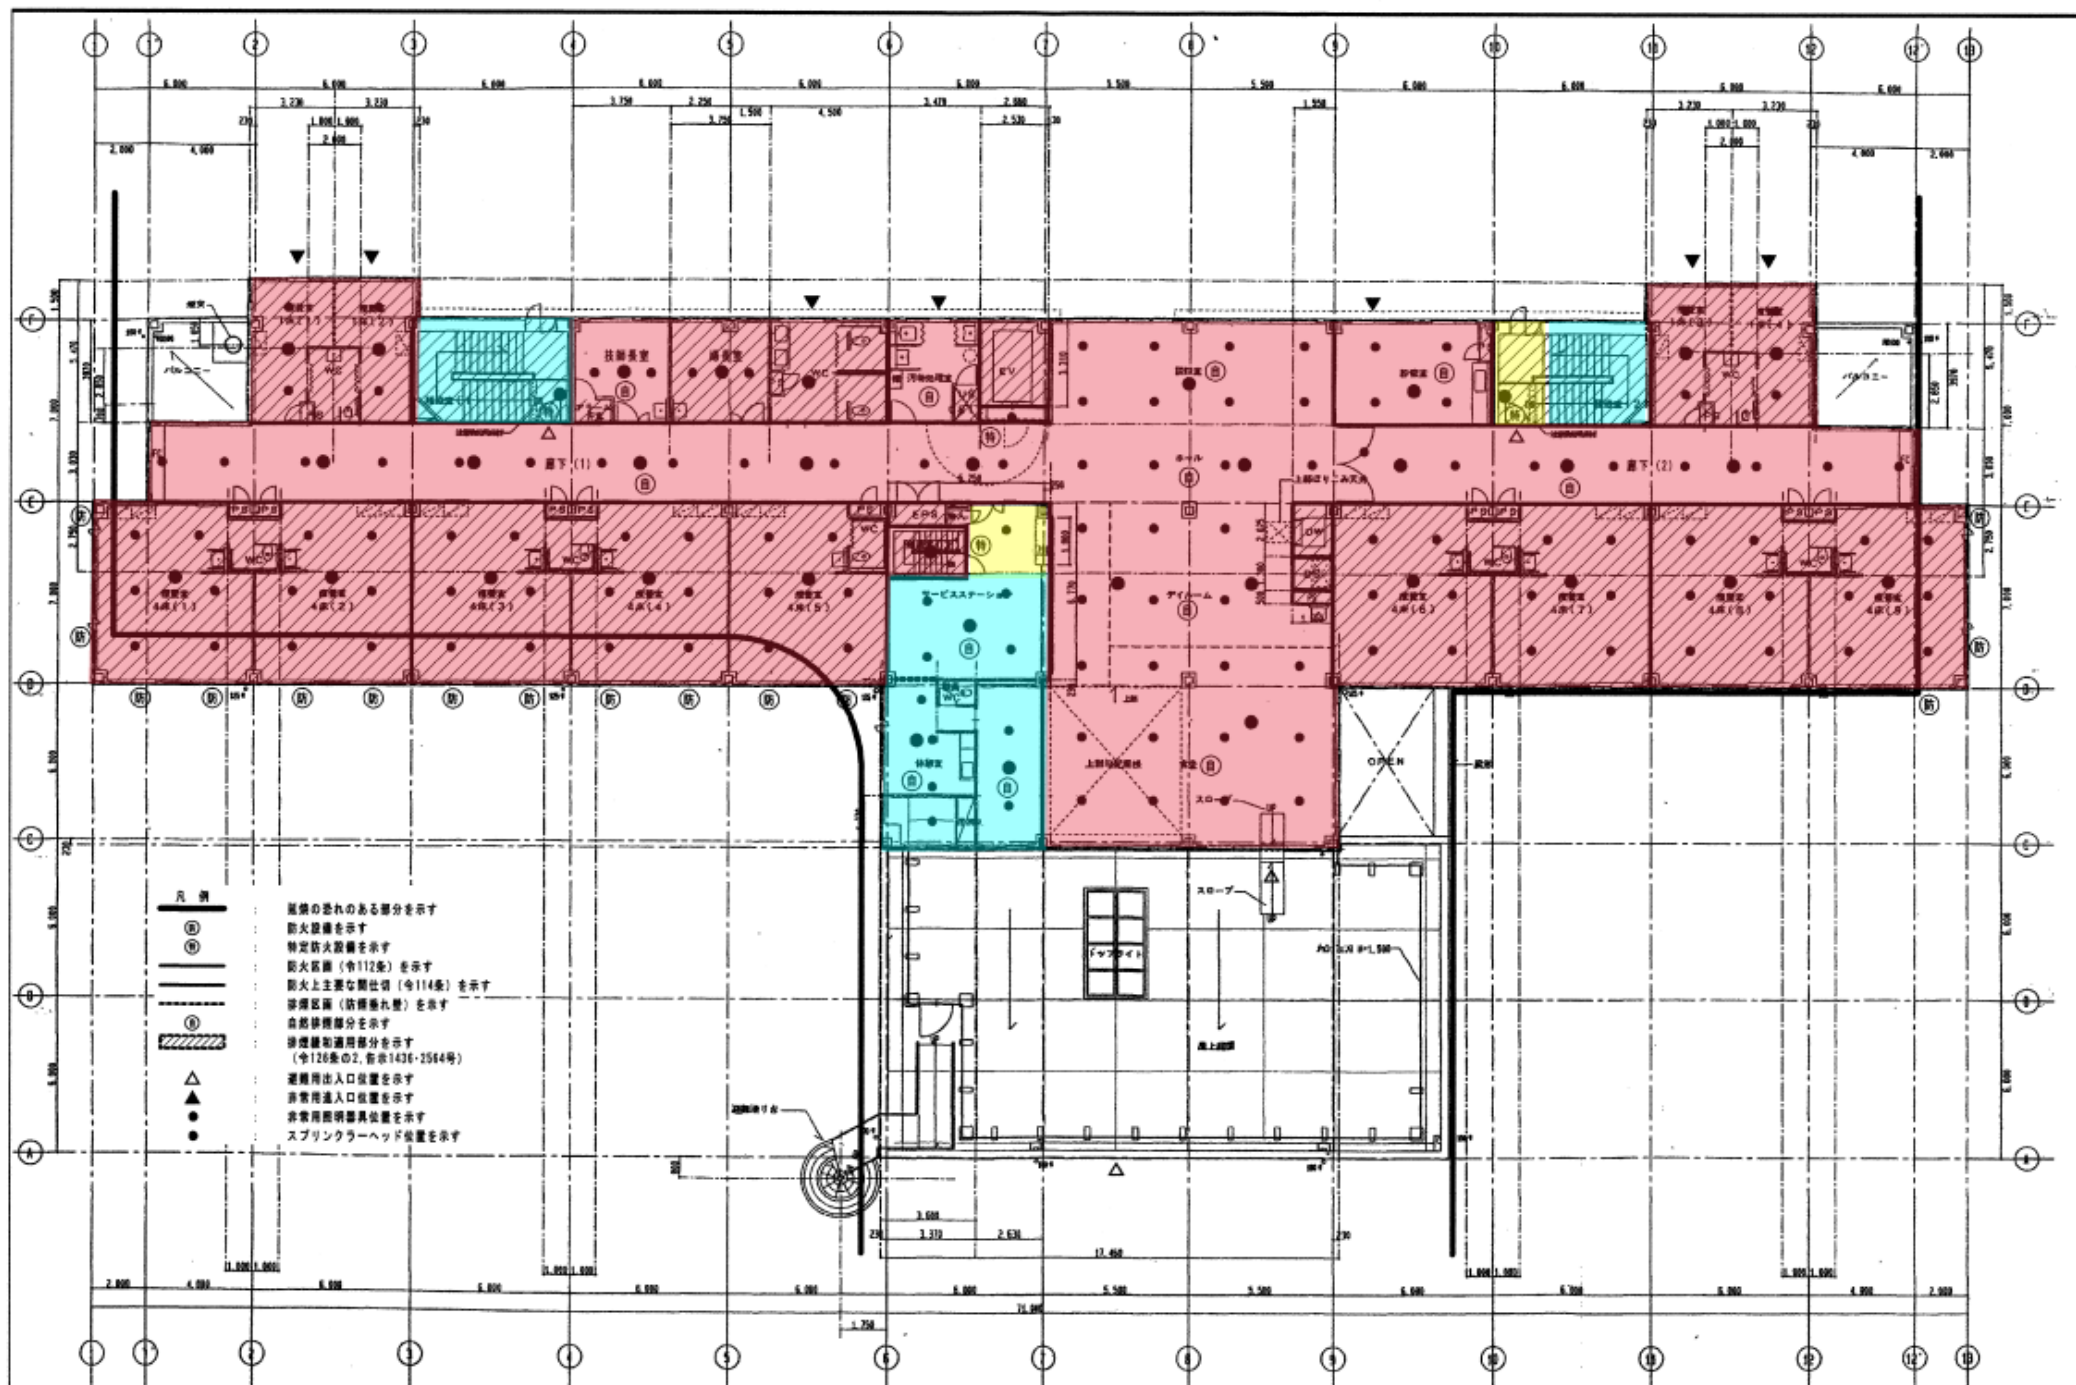

記事 _____ _____ _____		作成	全図	No.	図面名称 3 階平面図 縮尺 A1: 1/100 A3: 1/200
			4	4	